



SCALE: 1/4" = 1'-0"

1. EXIT SIGNS AND BALLAST LOAD TRANSFER RELAYS SHALL BE CONNECTED TO LIGHTING CIRCUIT SERVING AREA AND AHEAD OF ALL SWITCHING.

3. LIGHT FIXTURE IN ROOM 205 SHALL NOT BE CONNECTED TO LIGHTING CONTROL PANEL.



Wilcox
Professional Services


1142.00024

CITY OF SAULT STE. MARIE, MI
SAULT STE. MARIE, MI

SECOND FLOOR PLAN - LIGHTING

PREPARED UNDER THE
SUPERVISION OF:

[illegible]

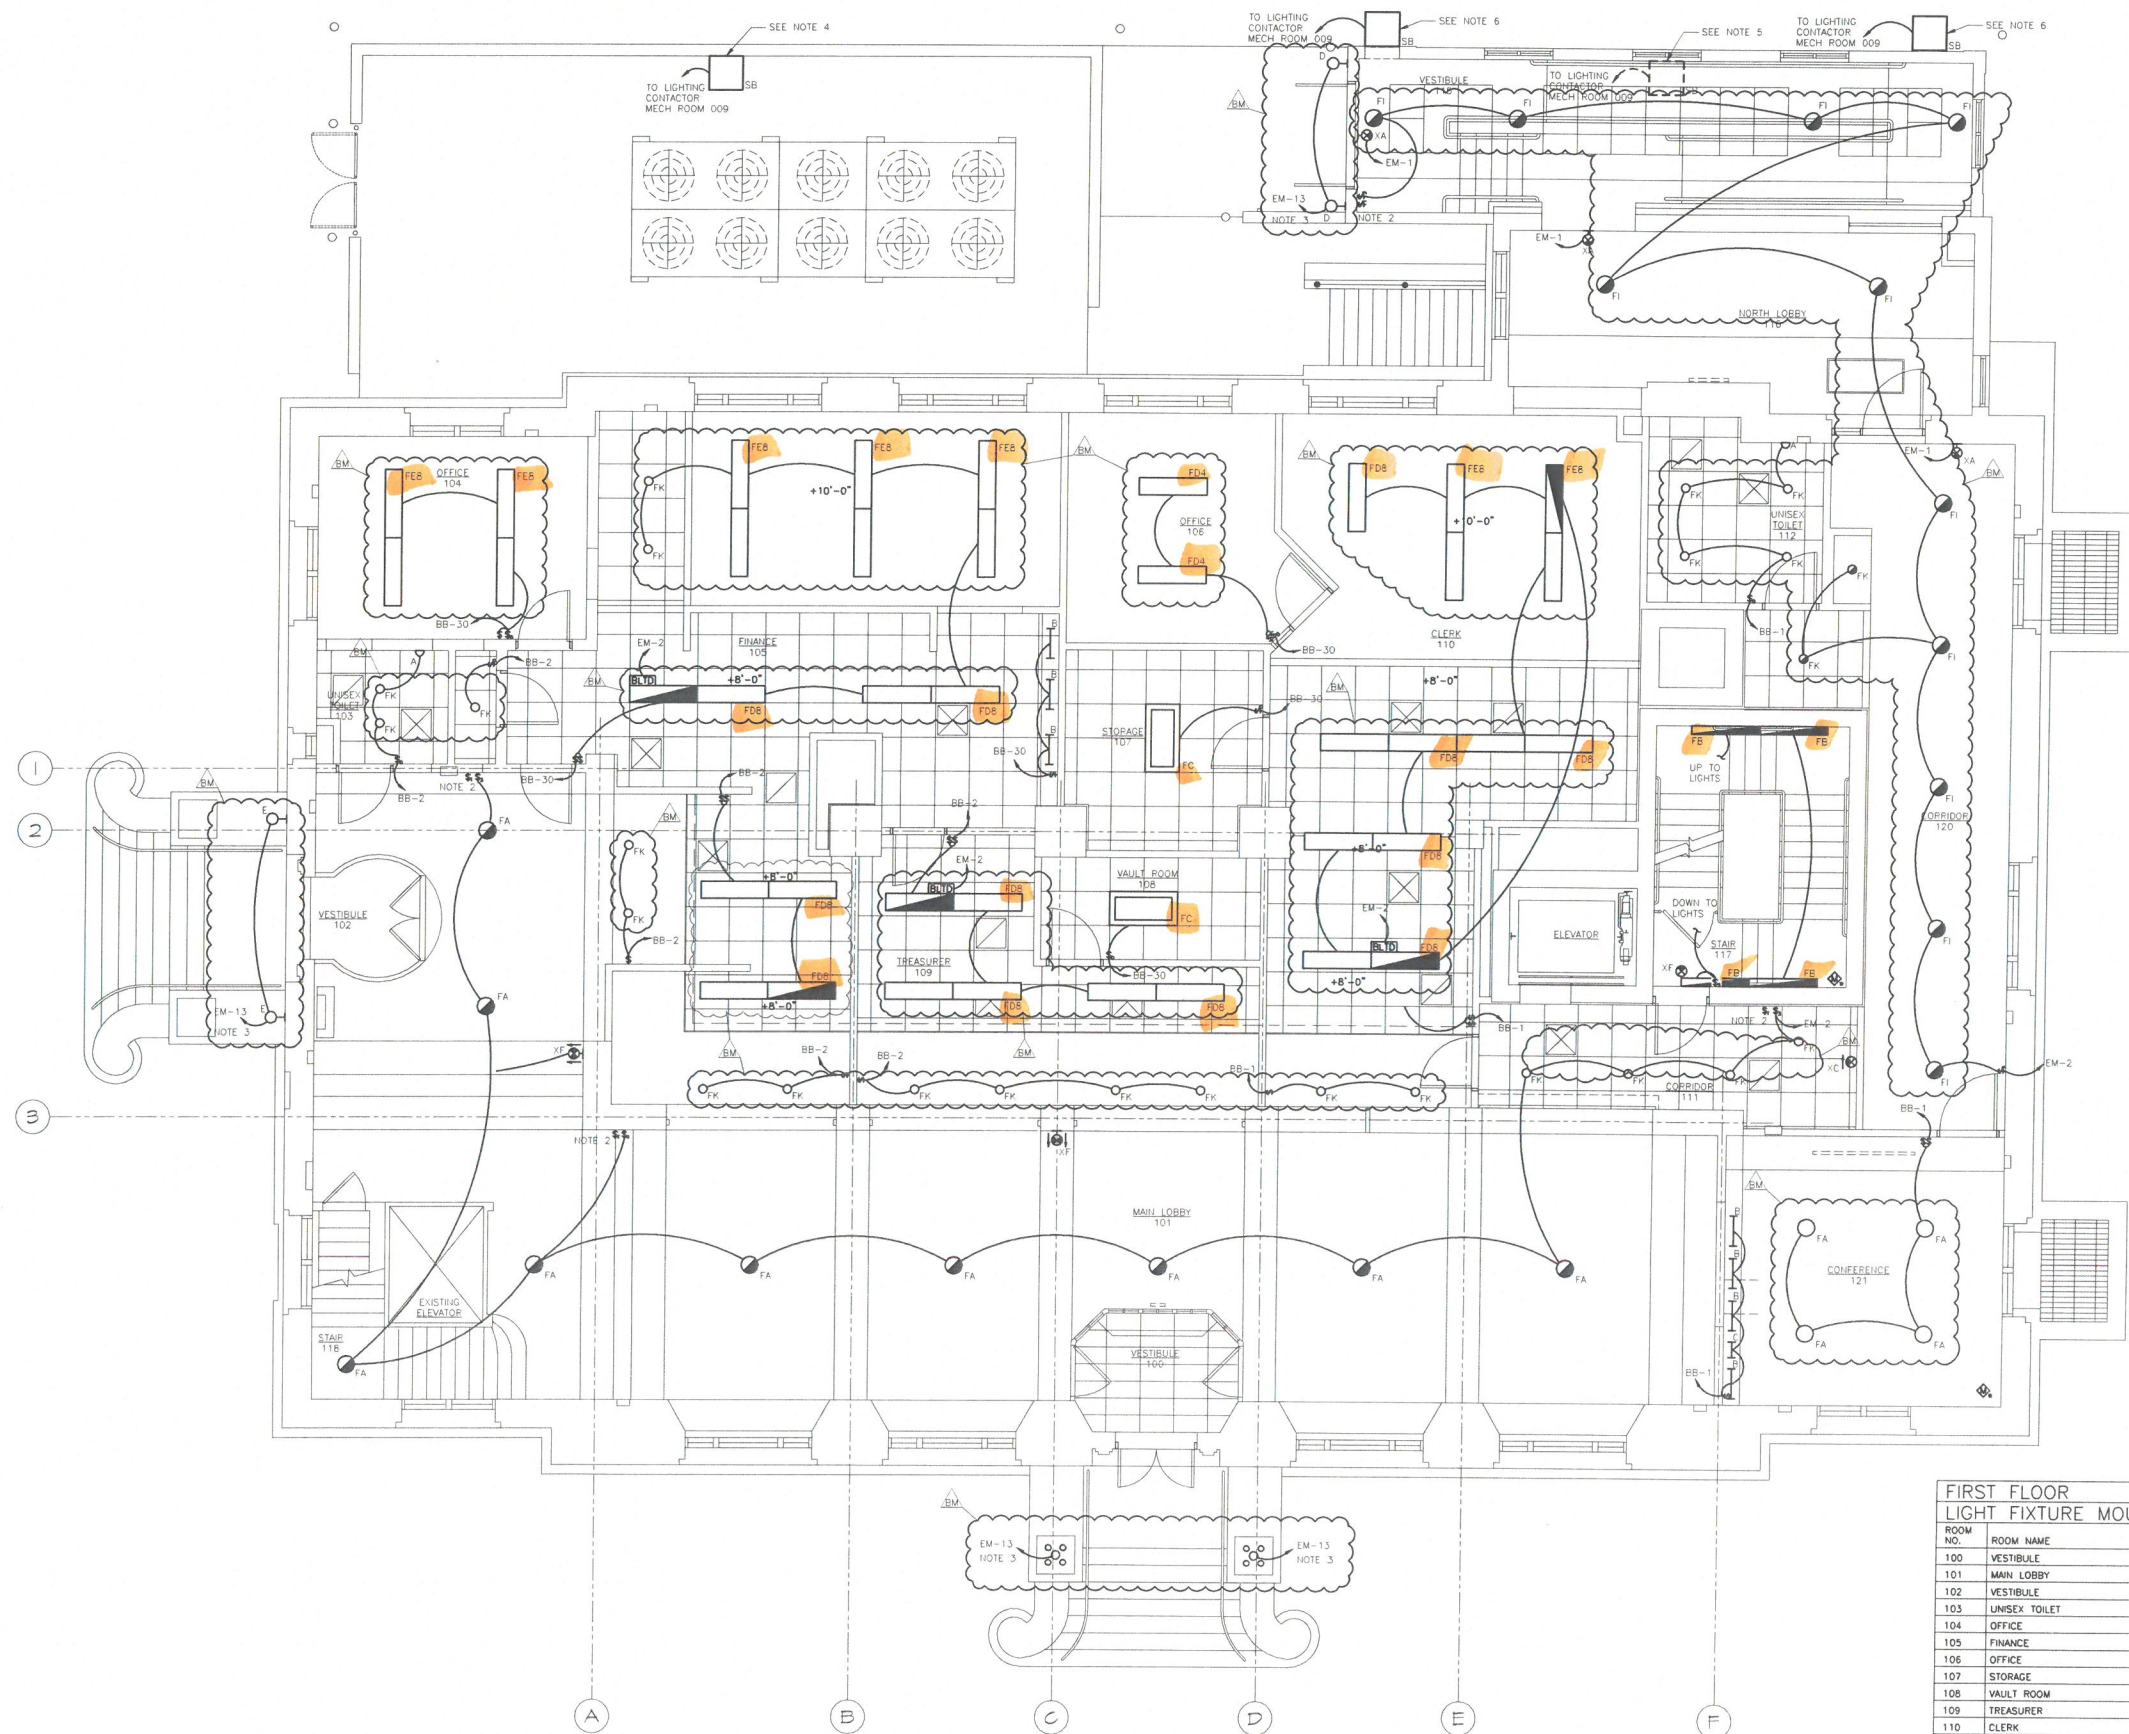

FIRST FLOOR PLAN - LIGHTING

SCALE: 1/4" = 1'-0"

NOTES:

- EXIT SIGNS AND BALLAST LOAD TRANSFER RELAYS SHALL BE CONNECTED TO LIGHTING CIRCUIT SERVING AREA AND AHEAD OF ALL SWITCHING.
- SEE SEQUENCE OF OPERATIONS NOTES ON SHEET E-501 FOR WIRING OF SWITCHES.
- CONNECT FIXTURE TO EMERGENCY PANEL AND CONTACTOR AND ELTD.
- MOUNT LIGHT FIXTURE ON SCREEN WALL FACING UPWARD TO LIGHT BUILDING EXTERIOR.
- MOUNT LIGHT FIXTURE ON ADDITION ROOF FACING UPWARD TO LIGHT BUILDING EXTERIOR.
- MOUNT FIXTURE ON SIDE OF BUILDING AT 12'-0" ABOVE GROUND. ROTATE/TILT FIXTURE TO LIGHT ENTIRE PARKING LOT.

FIRST FLOOR
LIGHT FIXTURE MOUNTING HEIGHT TABLE

ROOM NO.	ROOM NAME	MOUNTING HEIGHT
100	VESTIBULE	N/A
101	MAIN LOBBY	12'-0"
102	VESTIBULE	N/A
103	UNISEX TOILET	8'-0"
104	OFFICE	10'-0"
105	FINANCE	SEE PLAN
106	OFFICE	10'-0"
107	STORAGE	8'-0"
108	VAULT ROOM	8'-0"
109	TREASURER	SEE PLAN
110	CLERK	SEE PLAN
111	CORRIDOR	12'-0"
112	UNISEX TOILET	9'-0"
113	NOT USED	N/A
114	NOT USED	N/A
115	VESTIBULE	12'-0"
116	NORTH LOBBY	12'-0"
117	STAIRS	7'-0"
118	STAIR	
119	NOT USED	N/A
120	CORRIDOR	12'-0"
121	CONFERENCE	8'-0"

PREPARED UNDER THE
SUPERVISION OF:

PROJECT LOG	
PROJECT NO.	11142.00024
PROJECT NAME	RENOVATIONS TO "THE FEDERAL BUILDING"
DESIGN BY	MPC
DRAWN BY	CLV
CHECKED BY	
SCALE	1"

CITY OF SAULT STE. MARIE, MI
SAULT STE. MARIE, MI



RENOVATIONS TO:
"THE FEDERAL BUILDING"
209 EAST PORTAGE AVENUE
CHIPPEWA COUNTY, MICHIGAN

FIRST FLOOR PLAN - LIGHTING

Wilcox
Professional Services

EL101

11142.00024

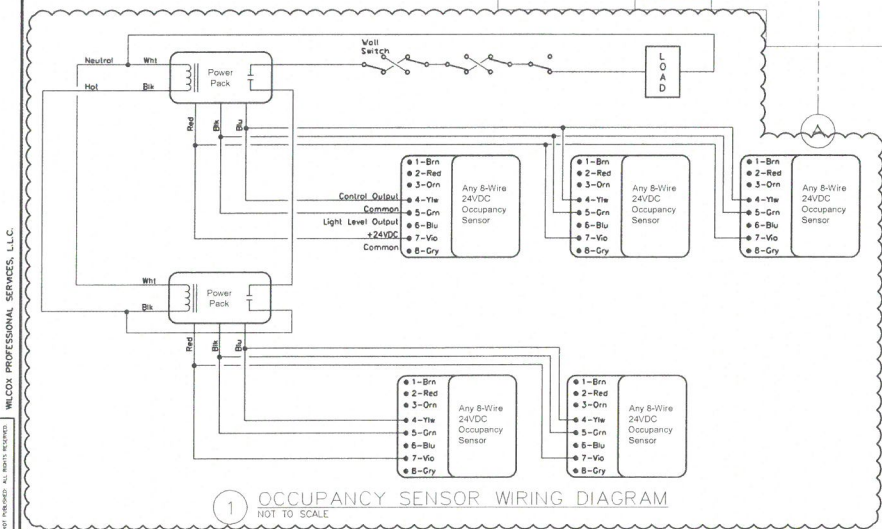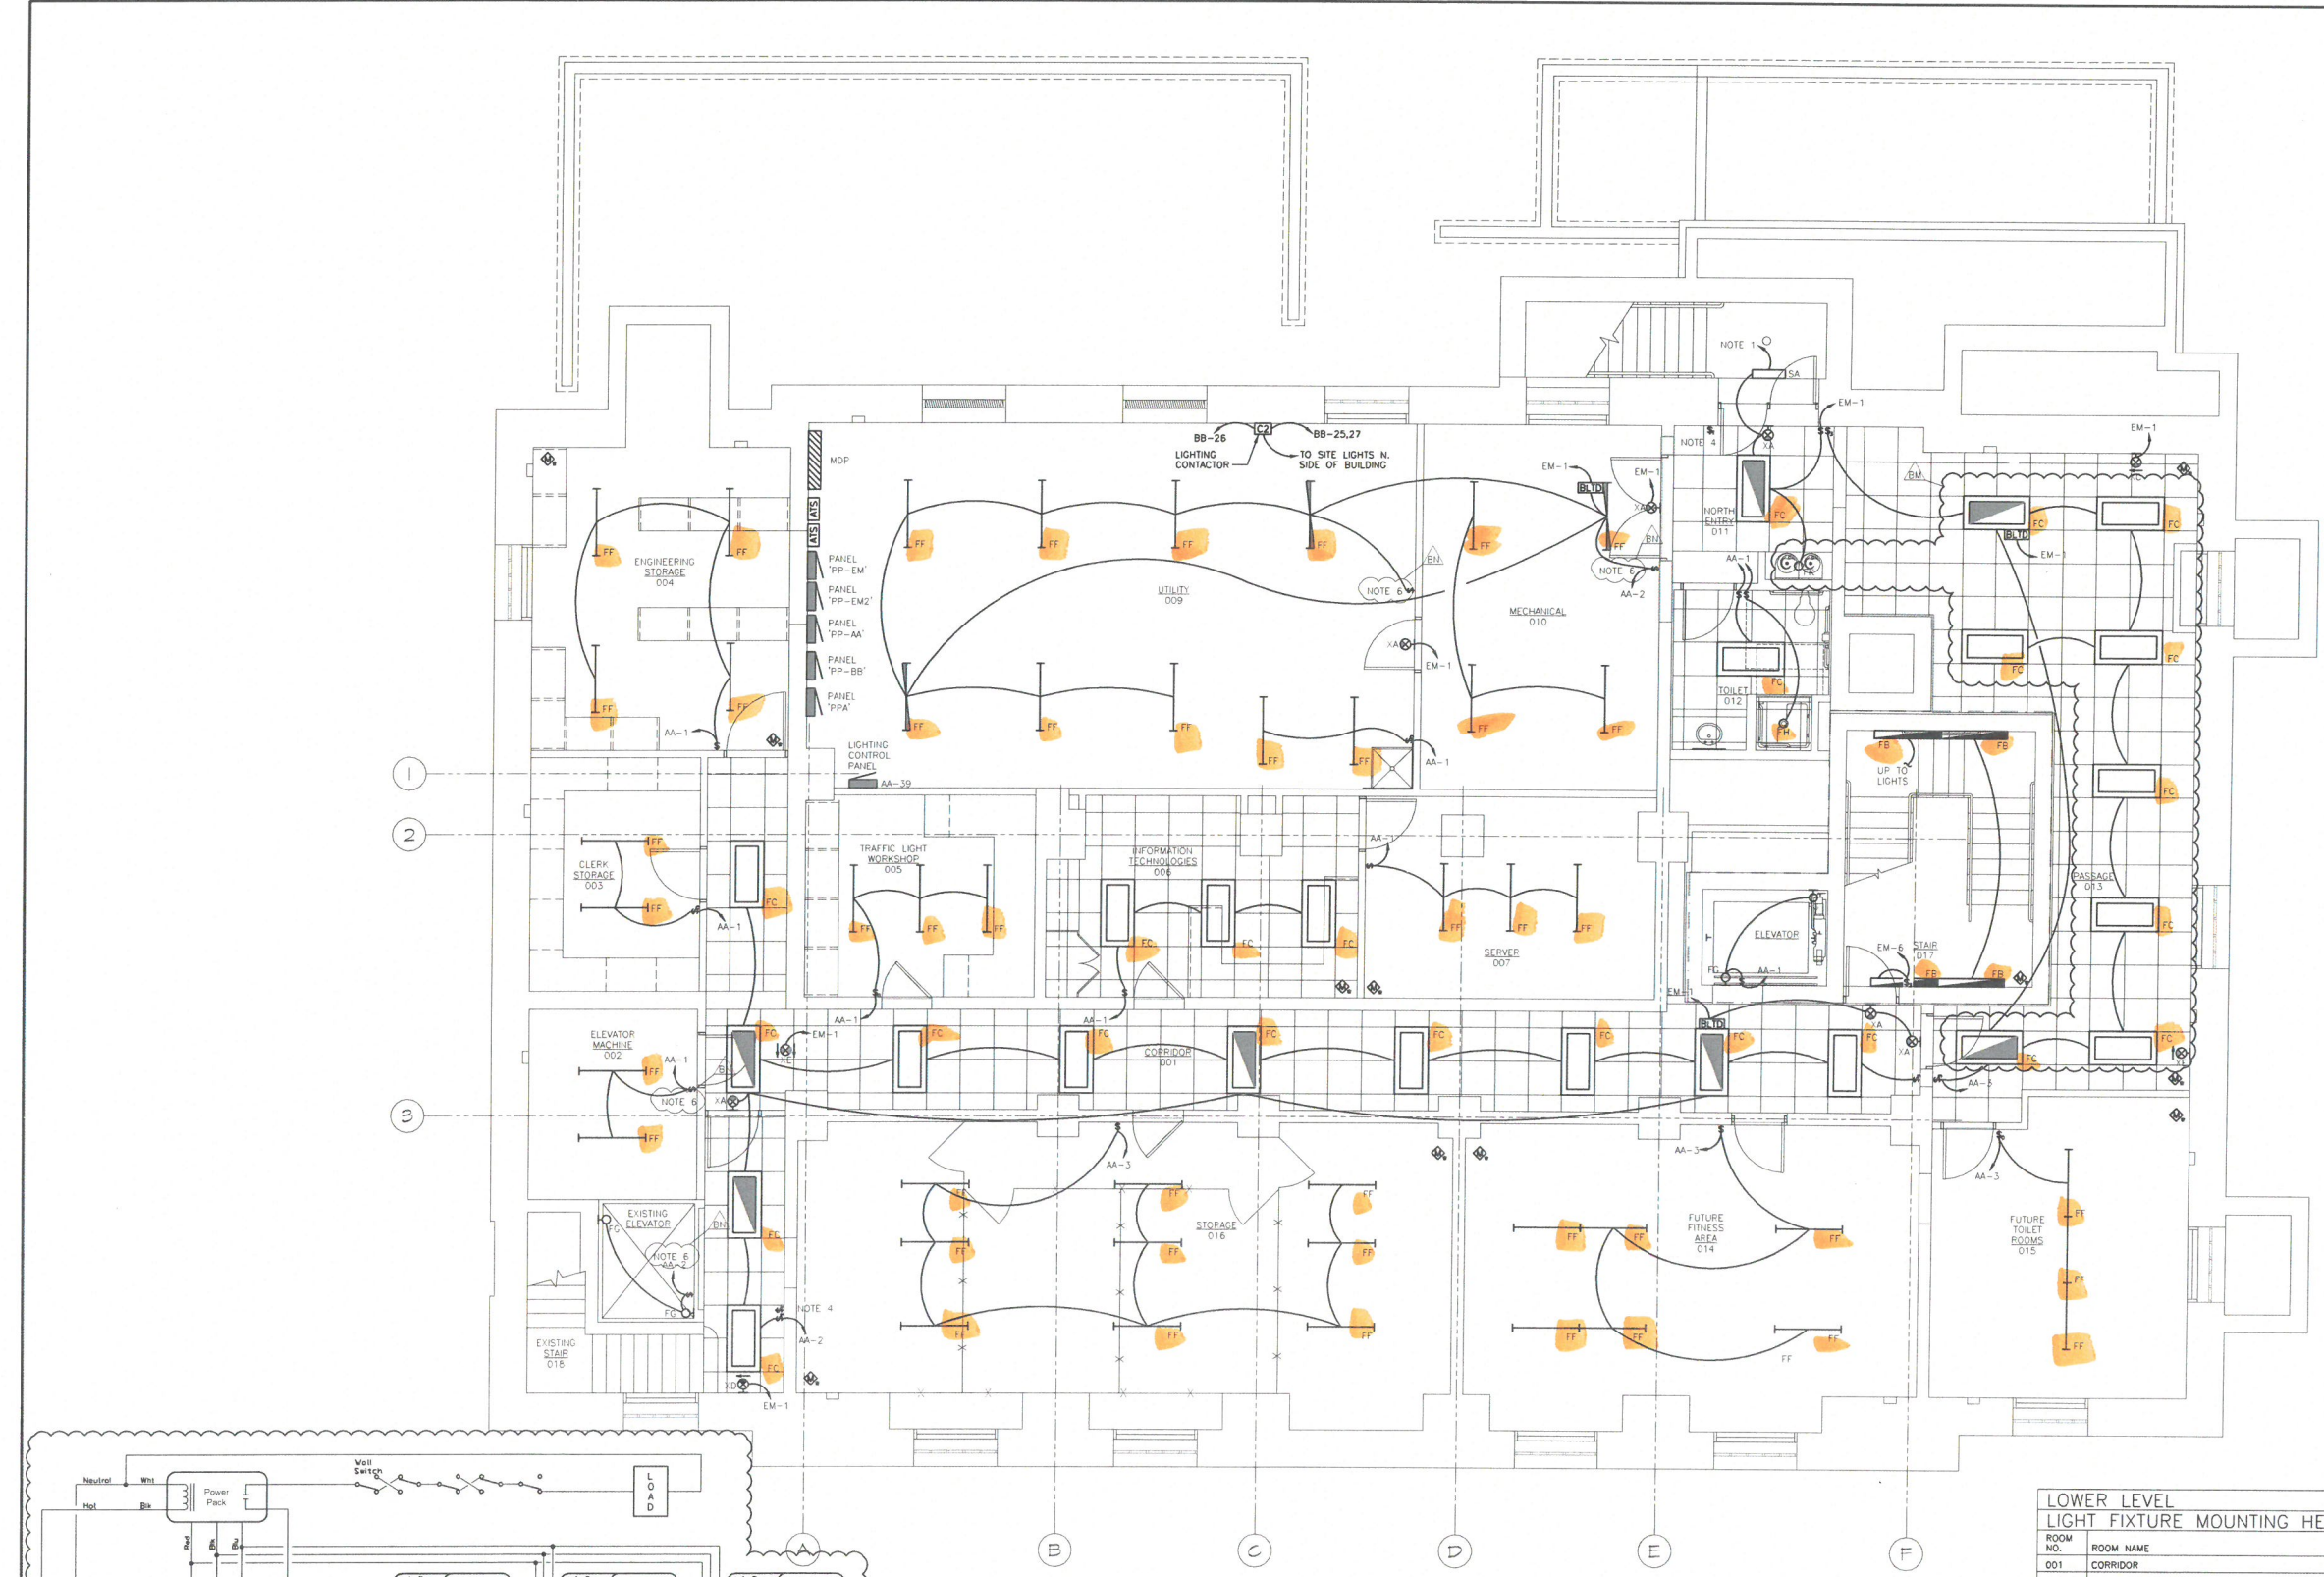

LOWER LEVEL FLOOR PLAN - LIGHTING
SCALE: 1/4" = 1'-0"

- NOTES:
1. CONNECT MAIN LAMP TO EXISTING SITE LIGHTING CIRCUIT AND CONTROL. EXTEND WIRE AND CONDUIT AS REQUIRED. CONNECT EMERGENCY HALOGEN LAMP TO LOCAL EMERGENCY LIGHTING CIRCUIT AHEAD OF ALL SWITCHING.
 2. EXIT SIGNS AND BALLAST LOAD TRANSFER RELAYS SHALL BE CONNECTED TO LIGHTING CIRCUIT SERVING AREA AND AHEAD OF ALL SWITCHING.
 3. MOUNT LIGHT FIXTURE ABOVE DOOR.
 4. SEE SEQUENCE OF OPERATIONS NOTES ON SHEET E-501 FOR WIRING OF SWITCHES.
 5. CHAIN HANG FIXTURES BELOW MECHANICAL EQUIPMENT. COORDINATE WITH MECHANICAL CONTRACTOR.
 6. LIGHT FIXTURES IN ROOMS 002, 009, 010, AND EXISTING ELEVATOR SHALL NOT BE CONNECTED TO LIGHTING CONTROL PANEL.

LOWER LEVEL LIGHT FIXTURE MOUNTING HEIGHT TABLE		
ROOM NO.	ROOM NAME	MOUNTING HEIGHT
001	CORRIDOR	9'-0"
002	ELEVATOR MACHINE	12'-0"
003	CLERK STORAGE	12'-0"
004	ENGINEERING STORAGE	12'-0"
005	TRAFFIC LIGHT WKSHOP	12'-0"
006	INFO. TECHNOLOGIES	9'-0"
007	SERVER	9'-0"
008	JANITOR CLOSET	12'-0"
009	UTILITY	12'-0"
010	MECHANICAL	9'-0"
011	NORTH ENTRY	9'-0"
012	TOILET	9'-0"
013	PASSAGE	9'-0"
014	FUTURE FITNESS AREA	12'-0"
015	FUTURE TOILET ROOMS	12'-0"
016	STORAGE	12'-0"
017	STAIR	7'-0"
018	EXISTING STAIR	N/A

PREPARED UNDER THE SUPERVISION OF:
PROJECT LOG
PROJECT NO. 11142.0004.30EL100
PROJECT NAME: RENOVATIONS TO "THE FEDERAL BUILDING"
PROJECT LOCATION: 209 EAST PORTAGE AVENUE, CHIPPewaUG COUNTY, MICHIGAN
PROJECT PHASE: CONSTRUCTION
PROJECT START DATE: 10/20/16
PROJECT END DATE: 10/20/16
DESIGN BY: MFC
DRAWN BY: CLV
CHECKED BY: SCALE: 1
FILE: 11142.0004.30EL100


CITY OF SAULT STE. MARIE, MI
SAULT STE. MARIE, MI

RENOVATIONS TO:
"THE FEDERAL BUILDING"
209 EAST PORTAGE AVENUE
CHIPPewaUG COUNTY, MICHIGAN

LOWER LEVEL FLOOR PLAN - LIGHTING

Wilcox Professional Services

EL100
11142.00024

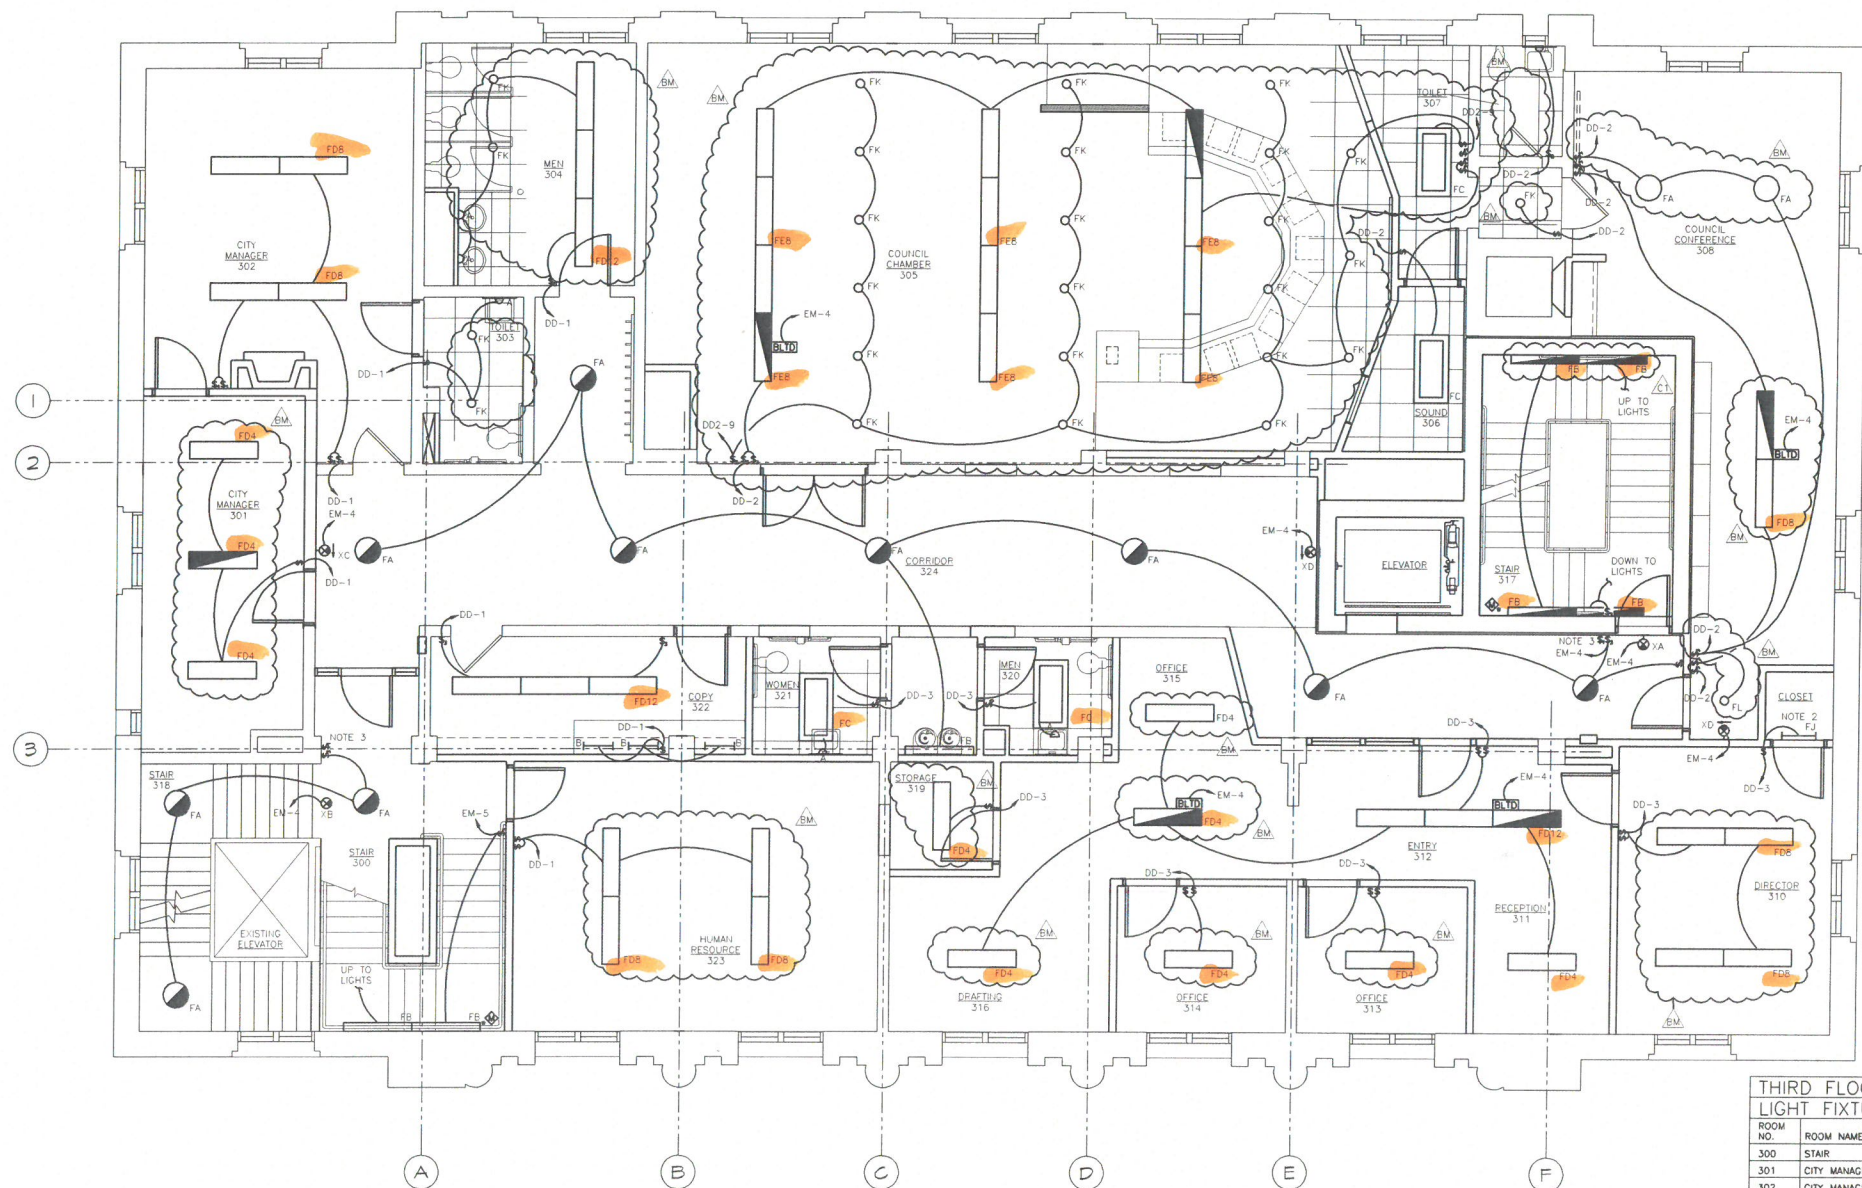

THIRD FLOOR PLAN - LIGHTING
SCALE: 1/4" = 1'-0"

- NOTES:
- EXIT SIGNS AND BALLAST LOAD TRANSFER RELAYS SHALL BE CONNECTED TO LIGHTING CIRCUIT SERVING AREA AND AHEAD OF ALL SWITCHING.
 - MOUNT LIGHT FIXTURE ABOVE DOOR.
 - SEE SEQUENCE OF OPERATIONS NOTES ON SHEET E-501 FOR WIRING OF SWITCHES.

THIRD FLOOR LIGHT FIXTURE MOUNTING HEIGHT TABLE		
ROOM NO.	ROOM NAME	MOUNTING HEIGHT
300	STAIR	10'-0"
301	CITY MANAGER	8'-0"
302	CITY MANAGER	8'-0"
303	TOILET	8'-0"
304	WOMEN	8'-0"
305	COUNCIL CHAMBERS	8'-0"
306	CLOSET	8'-0"
307	TOILET	8'-0"
308	COUNCIL CONFERENCE	8'-0"
309	NOT USED	N/A
310	DIRECTOR	8'-0"
311	RECEPTION	8'-0"
312	ENTRY	8'-0"
313	OFFICE	8'-0"
314	OFFICE	8'-0"
315	OFFICE	8'-0"
316	DRAFTING	8'-0"
317	STAIR	7'-0"
318	STAIR	10'-0"
319	STORAGE	8'-0"
320	UNISEX	8'-0"
321	UNISEX	8'-0"
322	COPY	8'-0"
323	HUMAN RESOURCES	8'-0"
324	CORRIDOR	10'-0"



EL103

1142.00024

RENOVATIONS TO:
"THE FEDERAL BUILDING"
200 EAST PORTAGE AVENUE
SAULT STE. MARIE, MICHIGAN
CHIPPewa COUNTY, MICHIGAN

CITY OF SAULT STE. MARIE, MI
SAULT STE. MARIE, MI

THIRD FLOOR PLAN - LIGHTING

PROJECT LOG	
PROJECT NO.	1142.00024
PROJECT NAME	RENOVATIONS TO "THE FEDERAL BUILDING"
PROJECT LOCATION	200 EAST PORTAGE AVENUE, SAULT STE. MARIE, MI
PROJECT OWNER	CITY OF SAULT STE. MARIE, MI
PROJECT MANAGER	MRC
DESIGN BY	CLV
DRAWN BY	CLV
CHECKED BY	CLV
SCALE	1

